

RECORD DRAWING
May 2002


PROFESSIONAL ENGINEER
REGISTERED
10081
PAUL E. DRUM

THIS DRAWING WAS PREPARED BY POWER ENGINEERS, INC. FOR A SPECIFIC PROJECT, TAKING INTO CONSIDERATION THE SPECIFIC AND UNIQUE REQUIREMENTS OF THE PROJECT. REUSE OF THIS DRAWING OR ANY INFORMATION CONTAINED IN THIS DRAWING FOR ANY PURPOSE IS PROHIBITED UNLESS WRITTEN PERMISSION FROM BOTH POWER AND POWER'S CLIENT IS GRANTED.



REV	REVISIONS	DATE	DRN	DSGN	CKD	APPD	REV	REVISIONS	DATE	DRN	DSGN	CKD	APPD	REFERENCE DRAWINGS
							△	ISSUED FOR RECORD	5/09/02	DGP	N/A	PED	PED	
							△	ISSUED FOR APPROVAL	2/08/01	DGP	KLJ	KLJ	WSK	
							△	ISSUED FOR REVIEW	12/29/00	DGP	KLJ	KLJ	WSK	* *

DSGN	KLJ	12/8/00
DRN	DGP	12/8/00
CKD	KLJ	12/8/00

SCALE: AS SHOWN
FOR 24x36 DWG ONLY

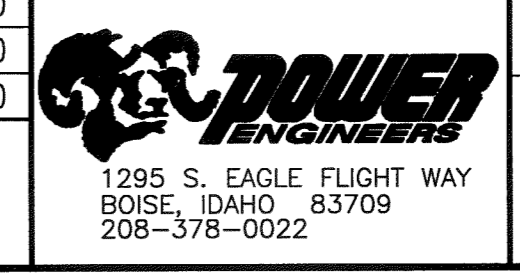


SWAN FALLS BUSINESS PARK NO. 1		JOB NUMBER 527785
PLAN AND PROFILE SEWER LINE B		DRAWING NO. C3.3
		REV △

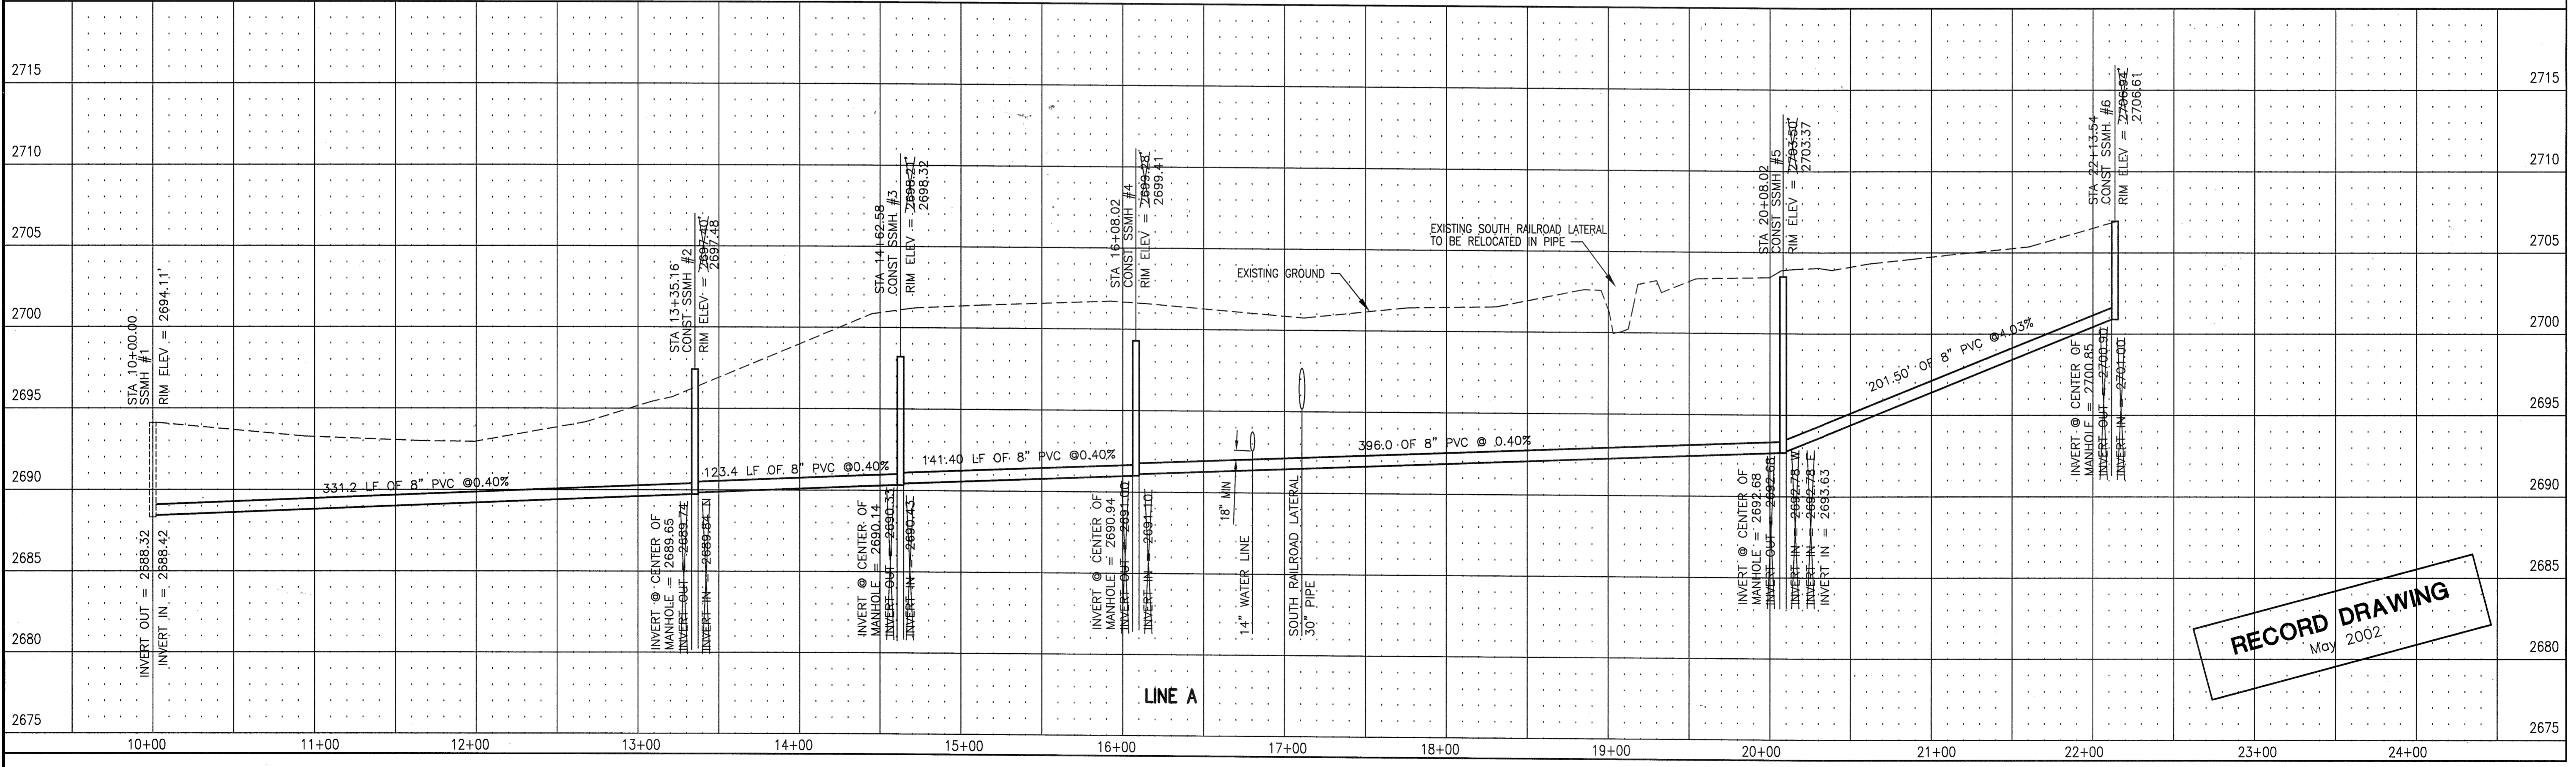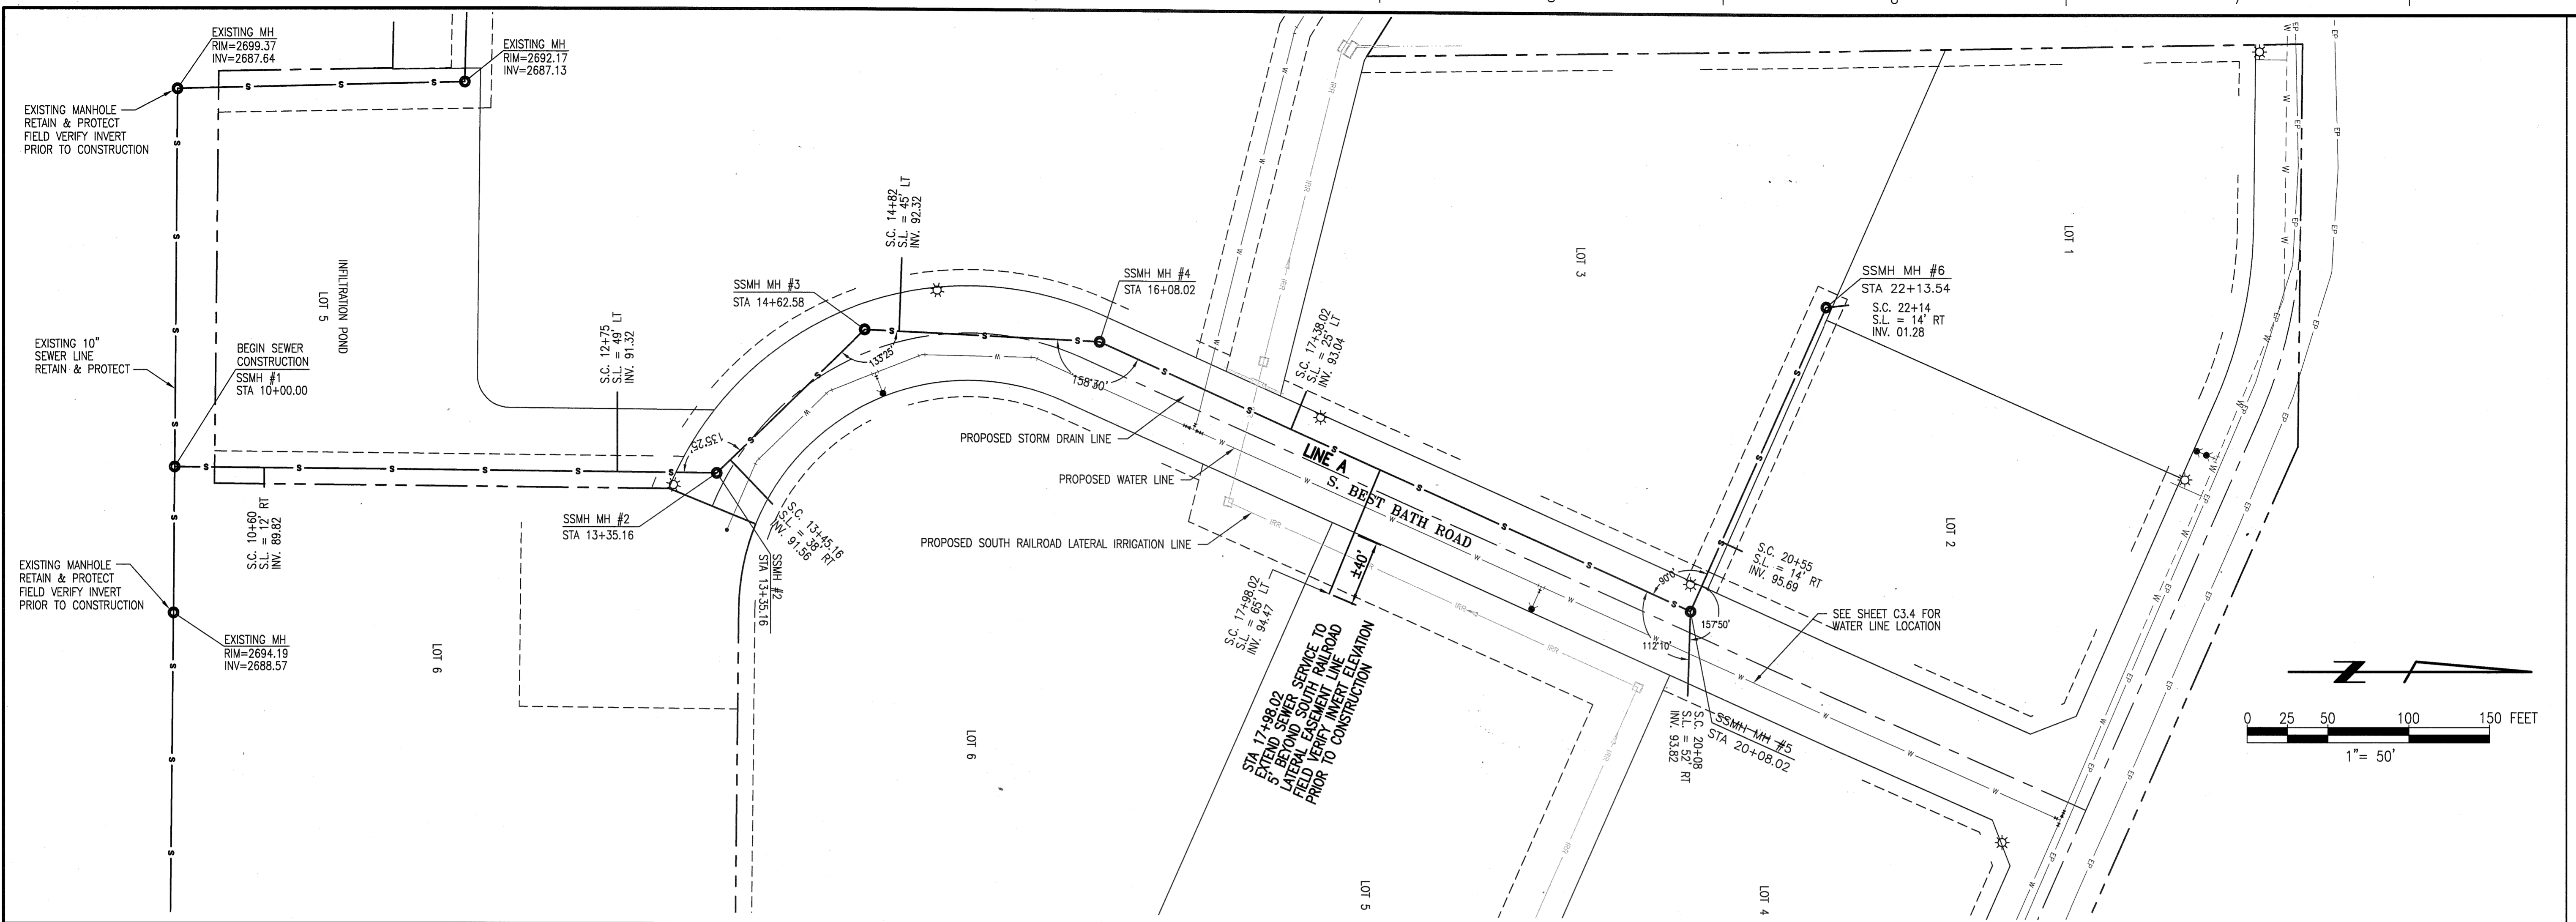

THIS DRAWING WAS PREPARED BY POWER ENGINEERS, INC. FOR A SPECIFIC PROJECT, TAKING INTO CONSIDERATION THE SPECIFIC AND UNIQUE REQUIREMENTS OF THE PROJECT. REUSE OF THIS DRAWING OR ANY INFORMATION CONTAINED IN THIS DRAWING FOR ANY PURPOSE IS PROHIBITED UNLESS WRITTEN PERMISSION FROM BOTH POWER AND POWER'S CLIENT IS GRANTED.

REV	REVISIONS	DATE	DRN	DSGN	CKD	APPD	REV	REVISIONS	DATE	DRN	DSGN	CKD	APPD
								ISSUED FOR RECORD	5/09/02	DGP	N/A	PED	PED
								ISSUED FOR APPROVAL	2/08/01	DGP	KLJ	KLJ	WSK
								ISSUED FOR REVIEW	12/29/00	DGP	KLJ	KLJ	WSK
													*
													*

DSGN	DLC	7/20/99
DRN	LE	7/20/99
CKD		
SCALE:	AS SHOWN	

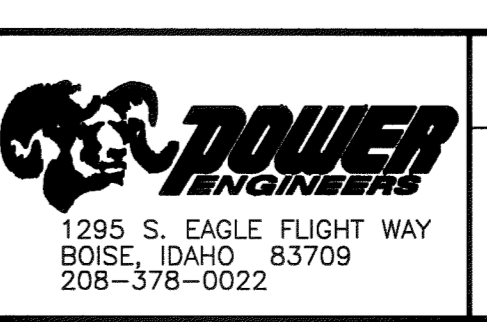

SWAN FALLS BUSINESS PARK NO. 1
 PLAN AND PROFILE
 SEWER LINE A

JOB NUMBER	527785
DRAWING NO.	C3.2
REV	2

